

LEGEND


- ① - POINT OF DISCONNECTION
- /// - AREA OF DEMOLITION

GENERAL NOTES


1. CONTRACTOR SHALL FIELD VERIFY EXACT PIPE SIZES OF ALL FIXTURES AND EQUIPMENT PRIOR TO BEGINNING ANY WORK.

DEMOLITION NOTES

- ① DISCONNECT AND REMOVE 5" MAIN FROM THE 3RD FLOOR DRY VALVE AS SHOWN.
- ② REMOVE SPRINKLER PIPING OVER 4".
- ③ DISCONNECT AND REMOVE 5" MAIN FROM THE 3RD FLOOR DRY VALVE AS SHOWN.
- ④ REMOVE SPRINKLER PIPING OVER 3-1/2".

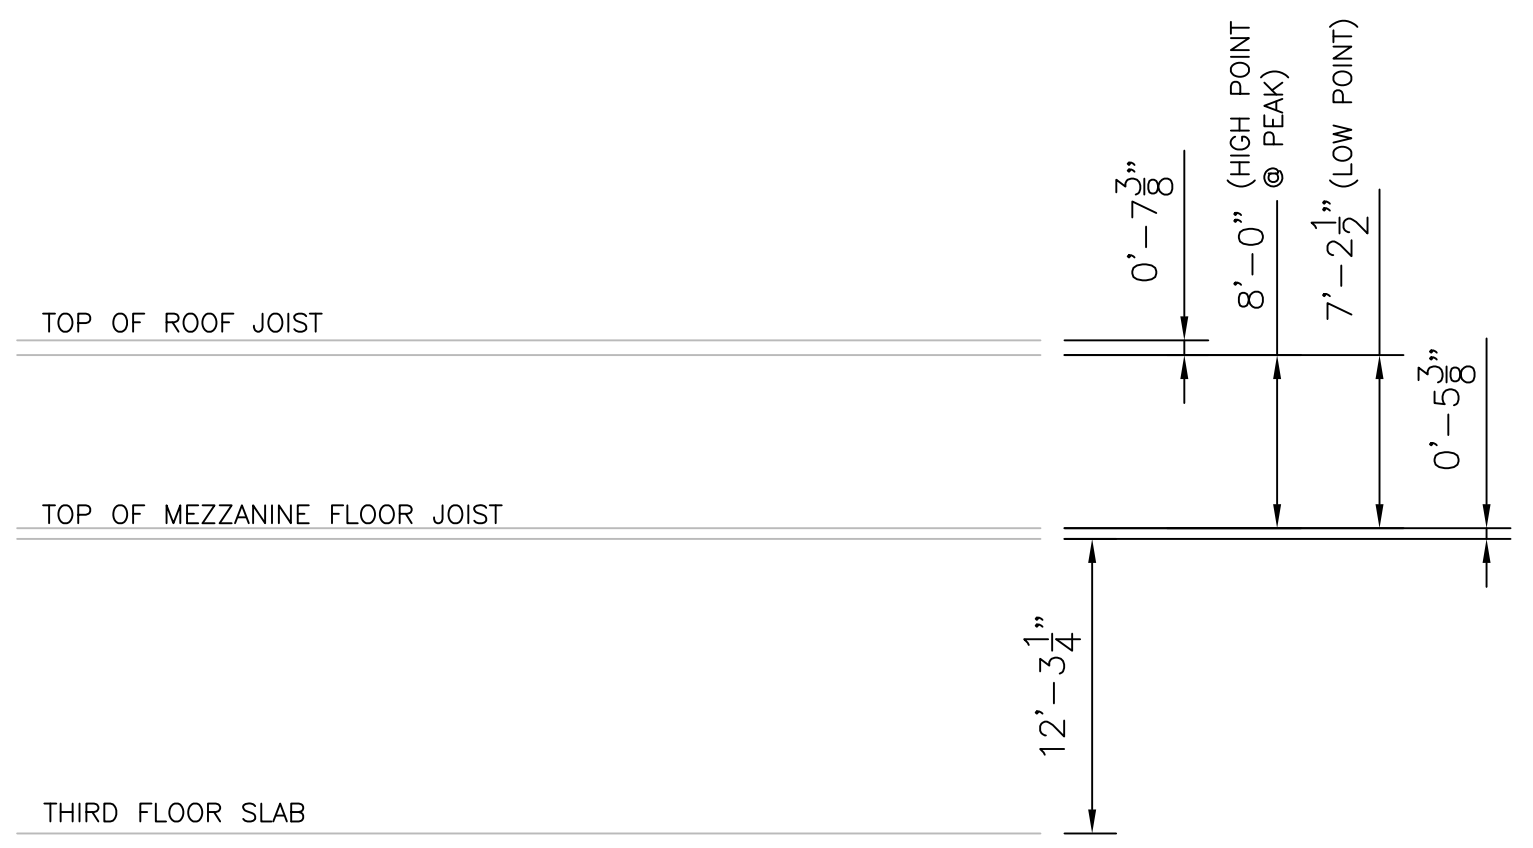

BUILDING "B" (NORTH)
- FIELD MEASUREMENTS -

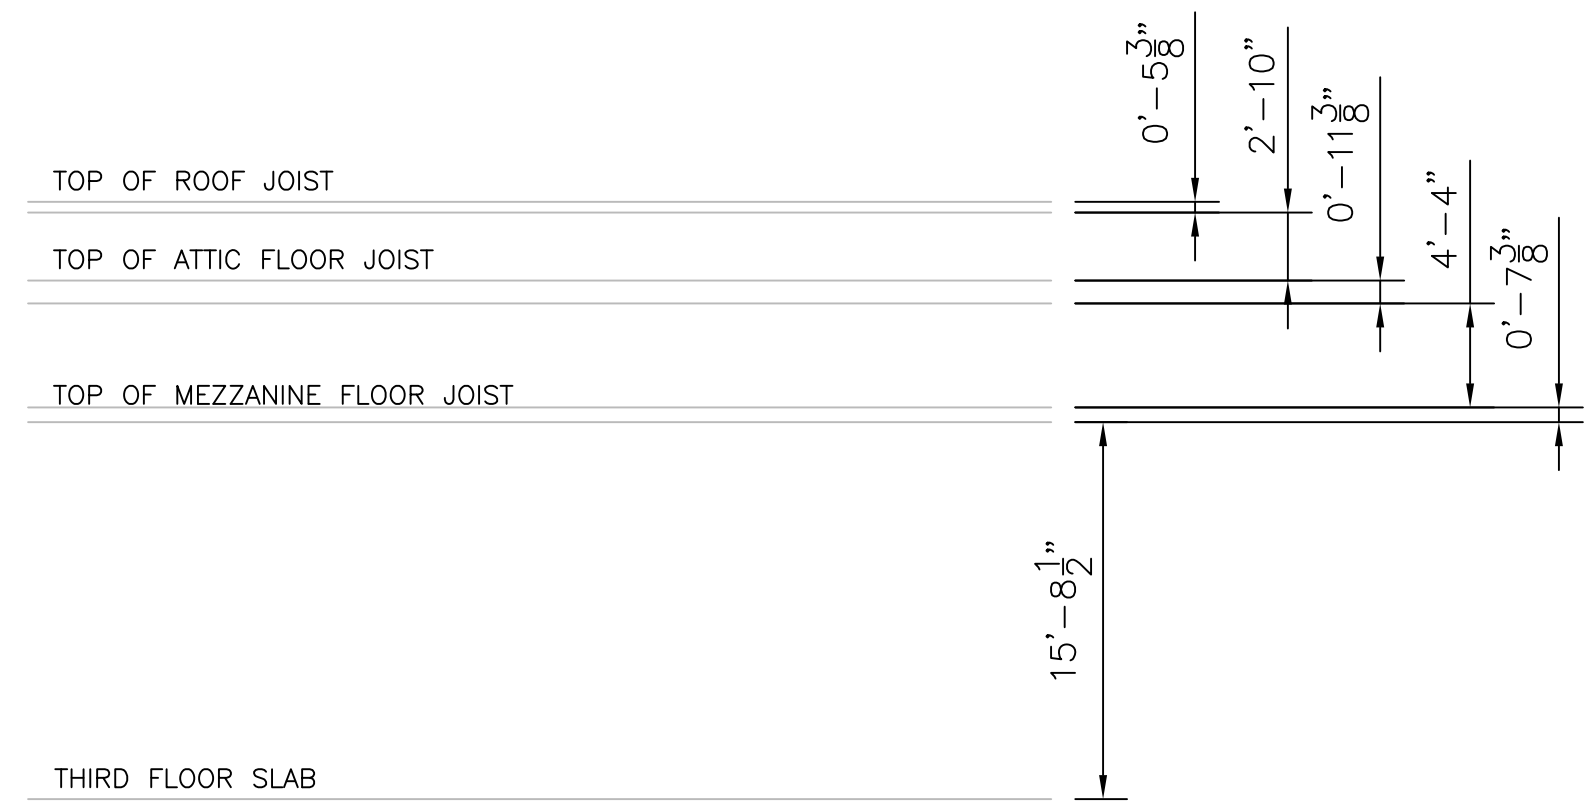

BUILDING "A" (SOUTH)
- FIELD MEASUREMENTS -

NOTICE

This document, the property of, prepared and issued by the architect, is submitted for the specific project named and the recipient by accepting this document assumes custody and agrees that this document will not be copied or reproduced in part or in whole, and any special features peculiar to this design shall not be incorporated in any other project, unless prior agreement has been obtained in writing. These documents will be returned immediately upon completion of the project or upon the request of the architect.

This document is the exclusive property of the architect, no rights to ownership are transferable, or shall be lost by the filing of this document with any and all public authorities for the purpose of compliance with Codes and or Ordinances, i.e. Building Permit, etc.

ERDMAN ANTHONY

2165 Brighton Henrietta Town Line Rd.
Rochester, NY 14623-2755
Telephone 585 427 8858
Facsimile 585 427 8914
www.erdmananthony.com

CHURCH OF THE HOLY FAMILY SENIOR APARTMENTS

920 TIFFT ST.
BUFFALO, NY 14220

REVISIONS:

SA PROJECT TEAM:	PRINCIPAL P. Silvestri
SR. ARCH.	JR. ARCH.
DRAWN BY LY	CHECKED BY AST

SEAL:

TITLE:
FIRE PROTECTION MEZZANINE PLAN DEMOLITION PIPING

SILVESTRI ARCHITECTS · PC

80 PINEVIEW DRIVE PH. 716.691.0900
AMHERST, NY 14228 FAX 716.691.4773

SA JOB #: 04312	DATE: 12-11-09
--------------------	-------------------

DRAWING #:
FPD-104